
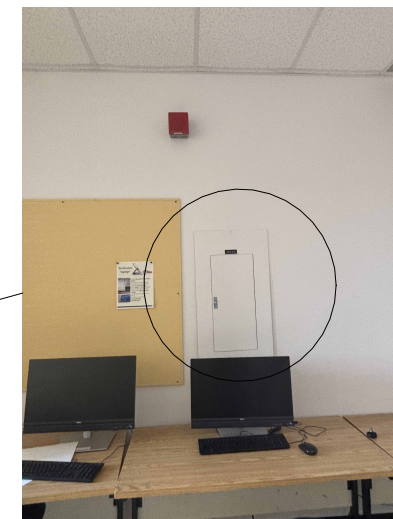


GENERAL NOTES

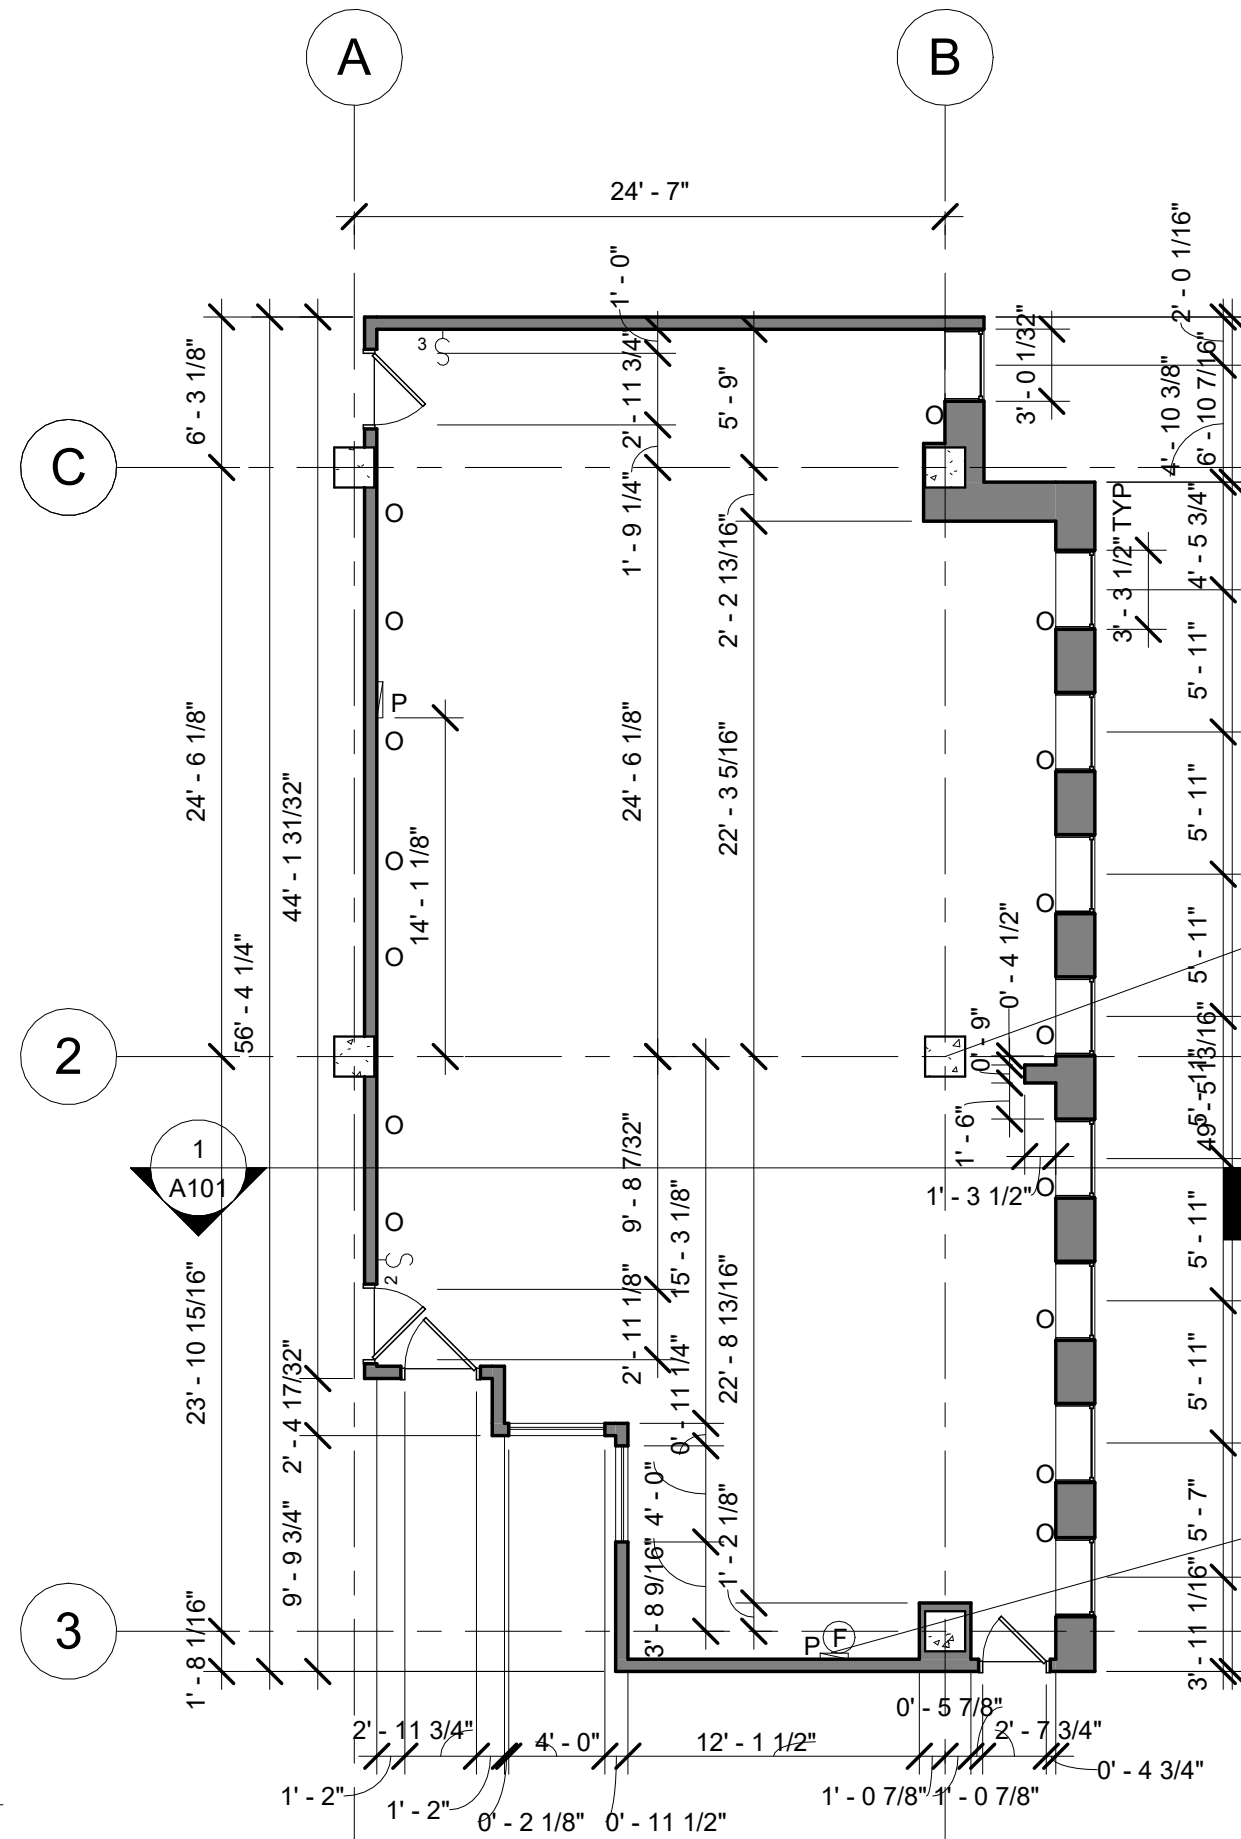

LEGEND	
P	ELECTRICAL PANEL
O	ELECTRICAL OUTLET
S ₃	TRIPLE SWITCH
S ₂	DOUBLE SWITCH

DRAWN BY

JOHANNA SONOKPON

PROJECT NAME

ROOM 319 SURVEY

SHEET NAME

FLOOR PLAN

PROJECT NUMBER

001

CHECKED BY

R.B.




DATE

09/08/25

SCALE

1/8" = 1'-0"

A101

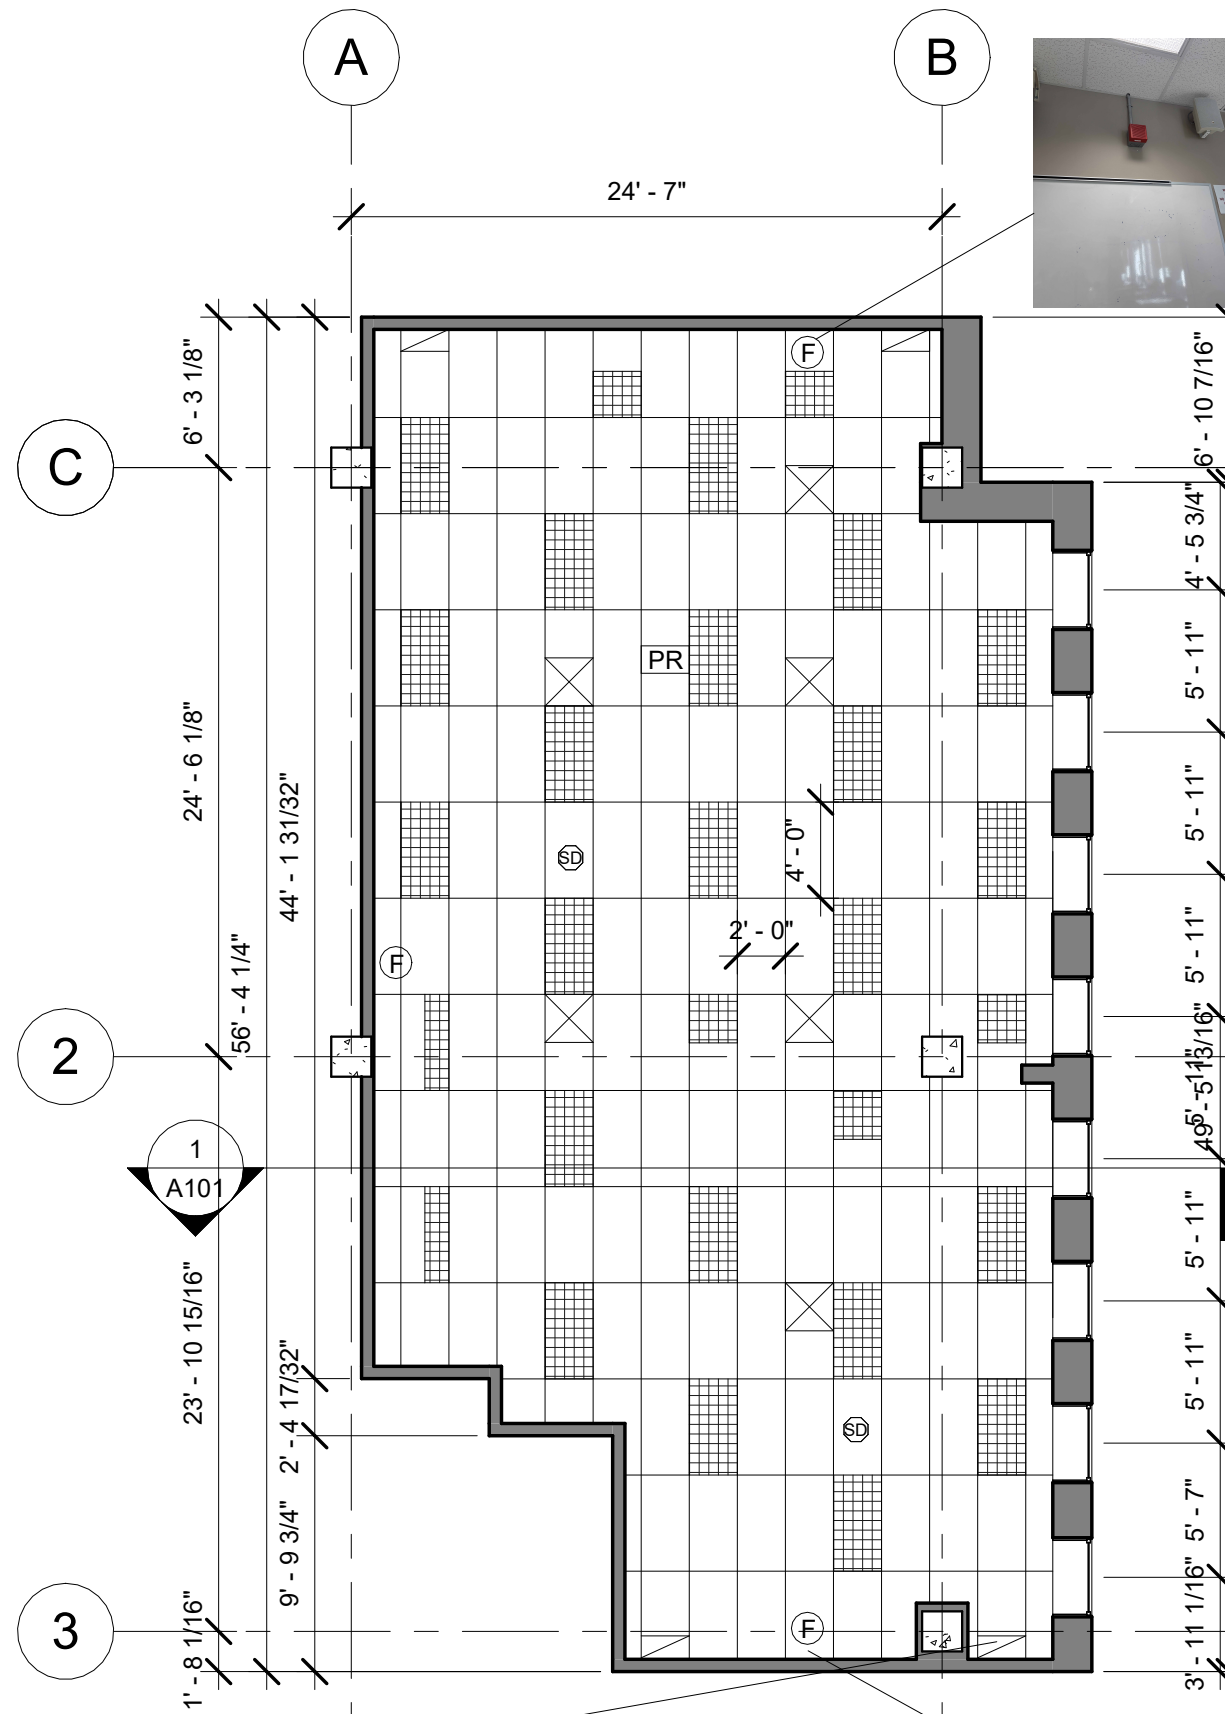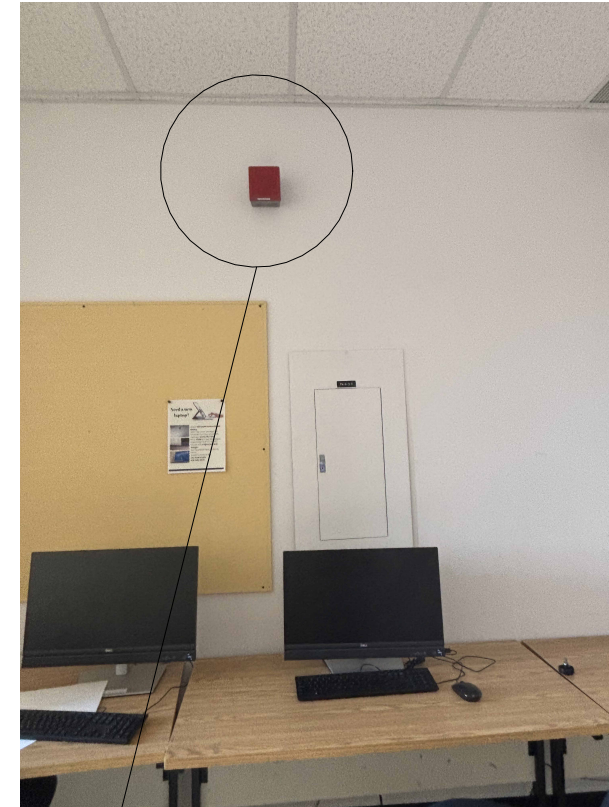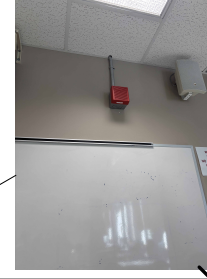

1 REFLECTED CEILING PLAN
1/8" = 1'-0"

LEGEND	
	LIGHT FIXTURE 2'X4'
	LIGHT FIXTURE 2'X2'
	LIGHT FIXTURE 1'X4'
	SMOKE DETECTOR
	SUPPLY AIR DIFFUSER
	RETURN AIR DIFFUSER
	MOTION SENSOR
	FIRE ALARM
	PROJECTOR

GENERAL NOTES

DRAWN BY
JOHANNA SONOKPON


PROJECT NAME
ROOM 319 SURVEY

SHEET NAME
RELECTED CEILING PLAN

PROJECT NUMBER
001
CHECKED BY
Checker
DATE
09/08/25
SCALE
1/8" = 1'-0"

A102

GENERAL NOTES

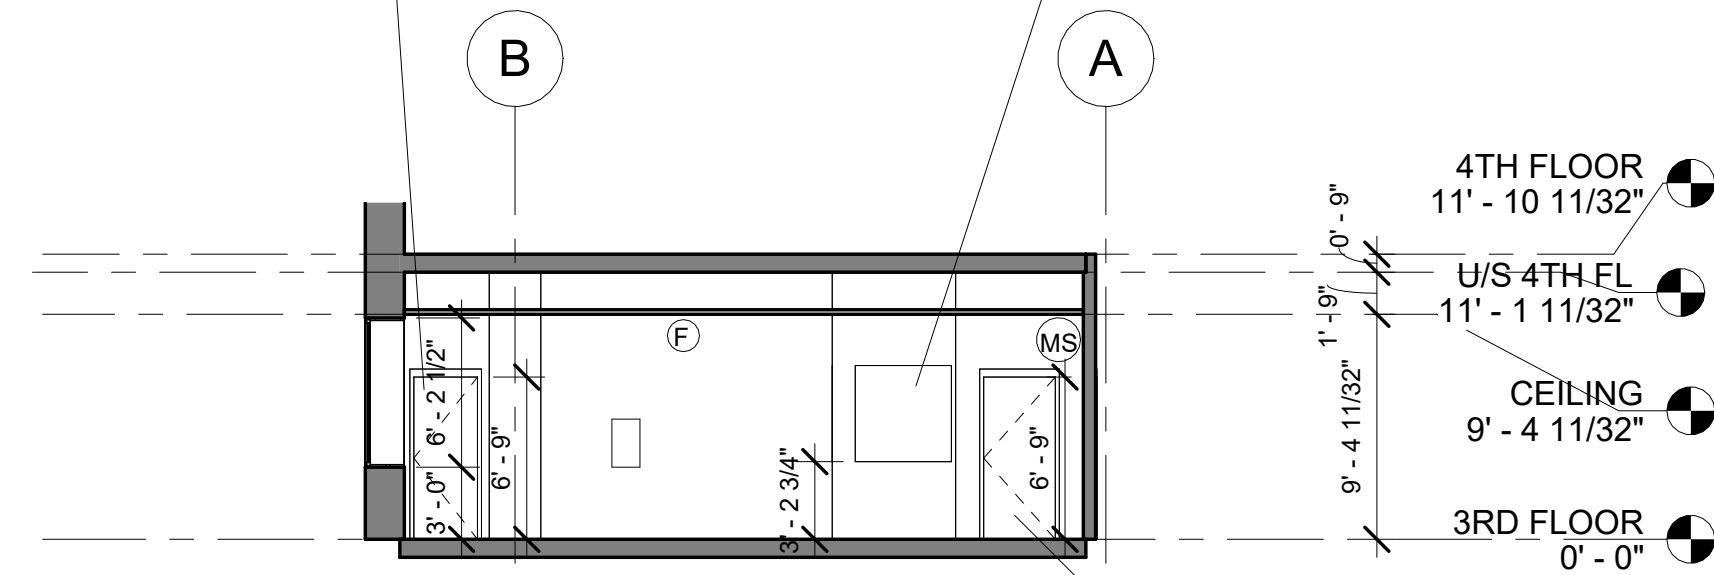

1 ROOM SECTION
1/8" = 1'-0"



LEGEND	
	LIGHT FIXTURE 2'X4'
	LIGHT FIXTURE 2'X2'
	LIGHT FIXTURE 1'X4'
	SMOKE DETECTOR
	SUPPLY AIR DIFFUSER
	RETURN AIR DIFFUSER
	MOTION SENSOR
	FIRE ALARM
	PROJECTOR

DRAWN BY
JOHANNA SONOKPON

PROJECT NAME
ROOM 319 SURVEY

SHEET NAME
ROOM SECTION

PROJECT NUMBER
001
CHECKED BY
R.B.
DATE
09/08/25
SCALE
1/8" = 1'-0"

A101