


GENERAL NOTES

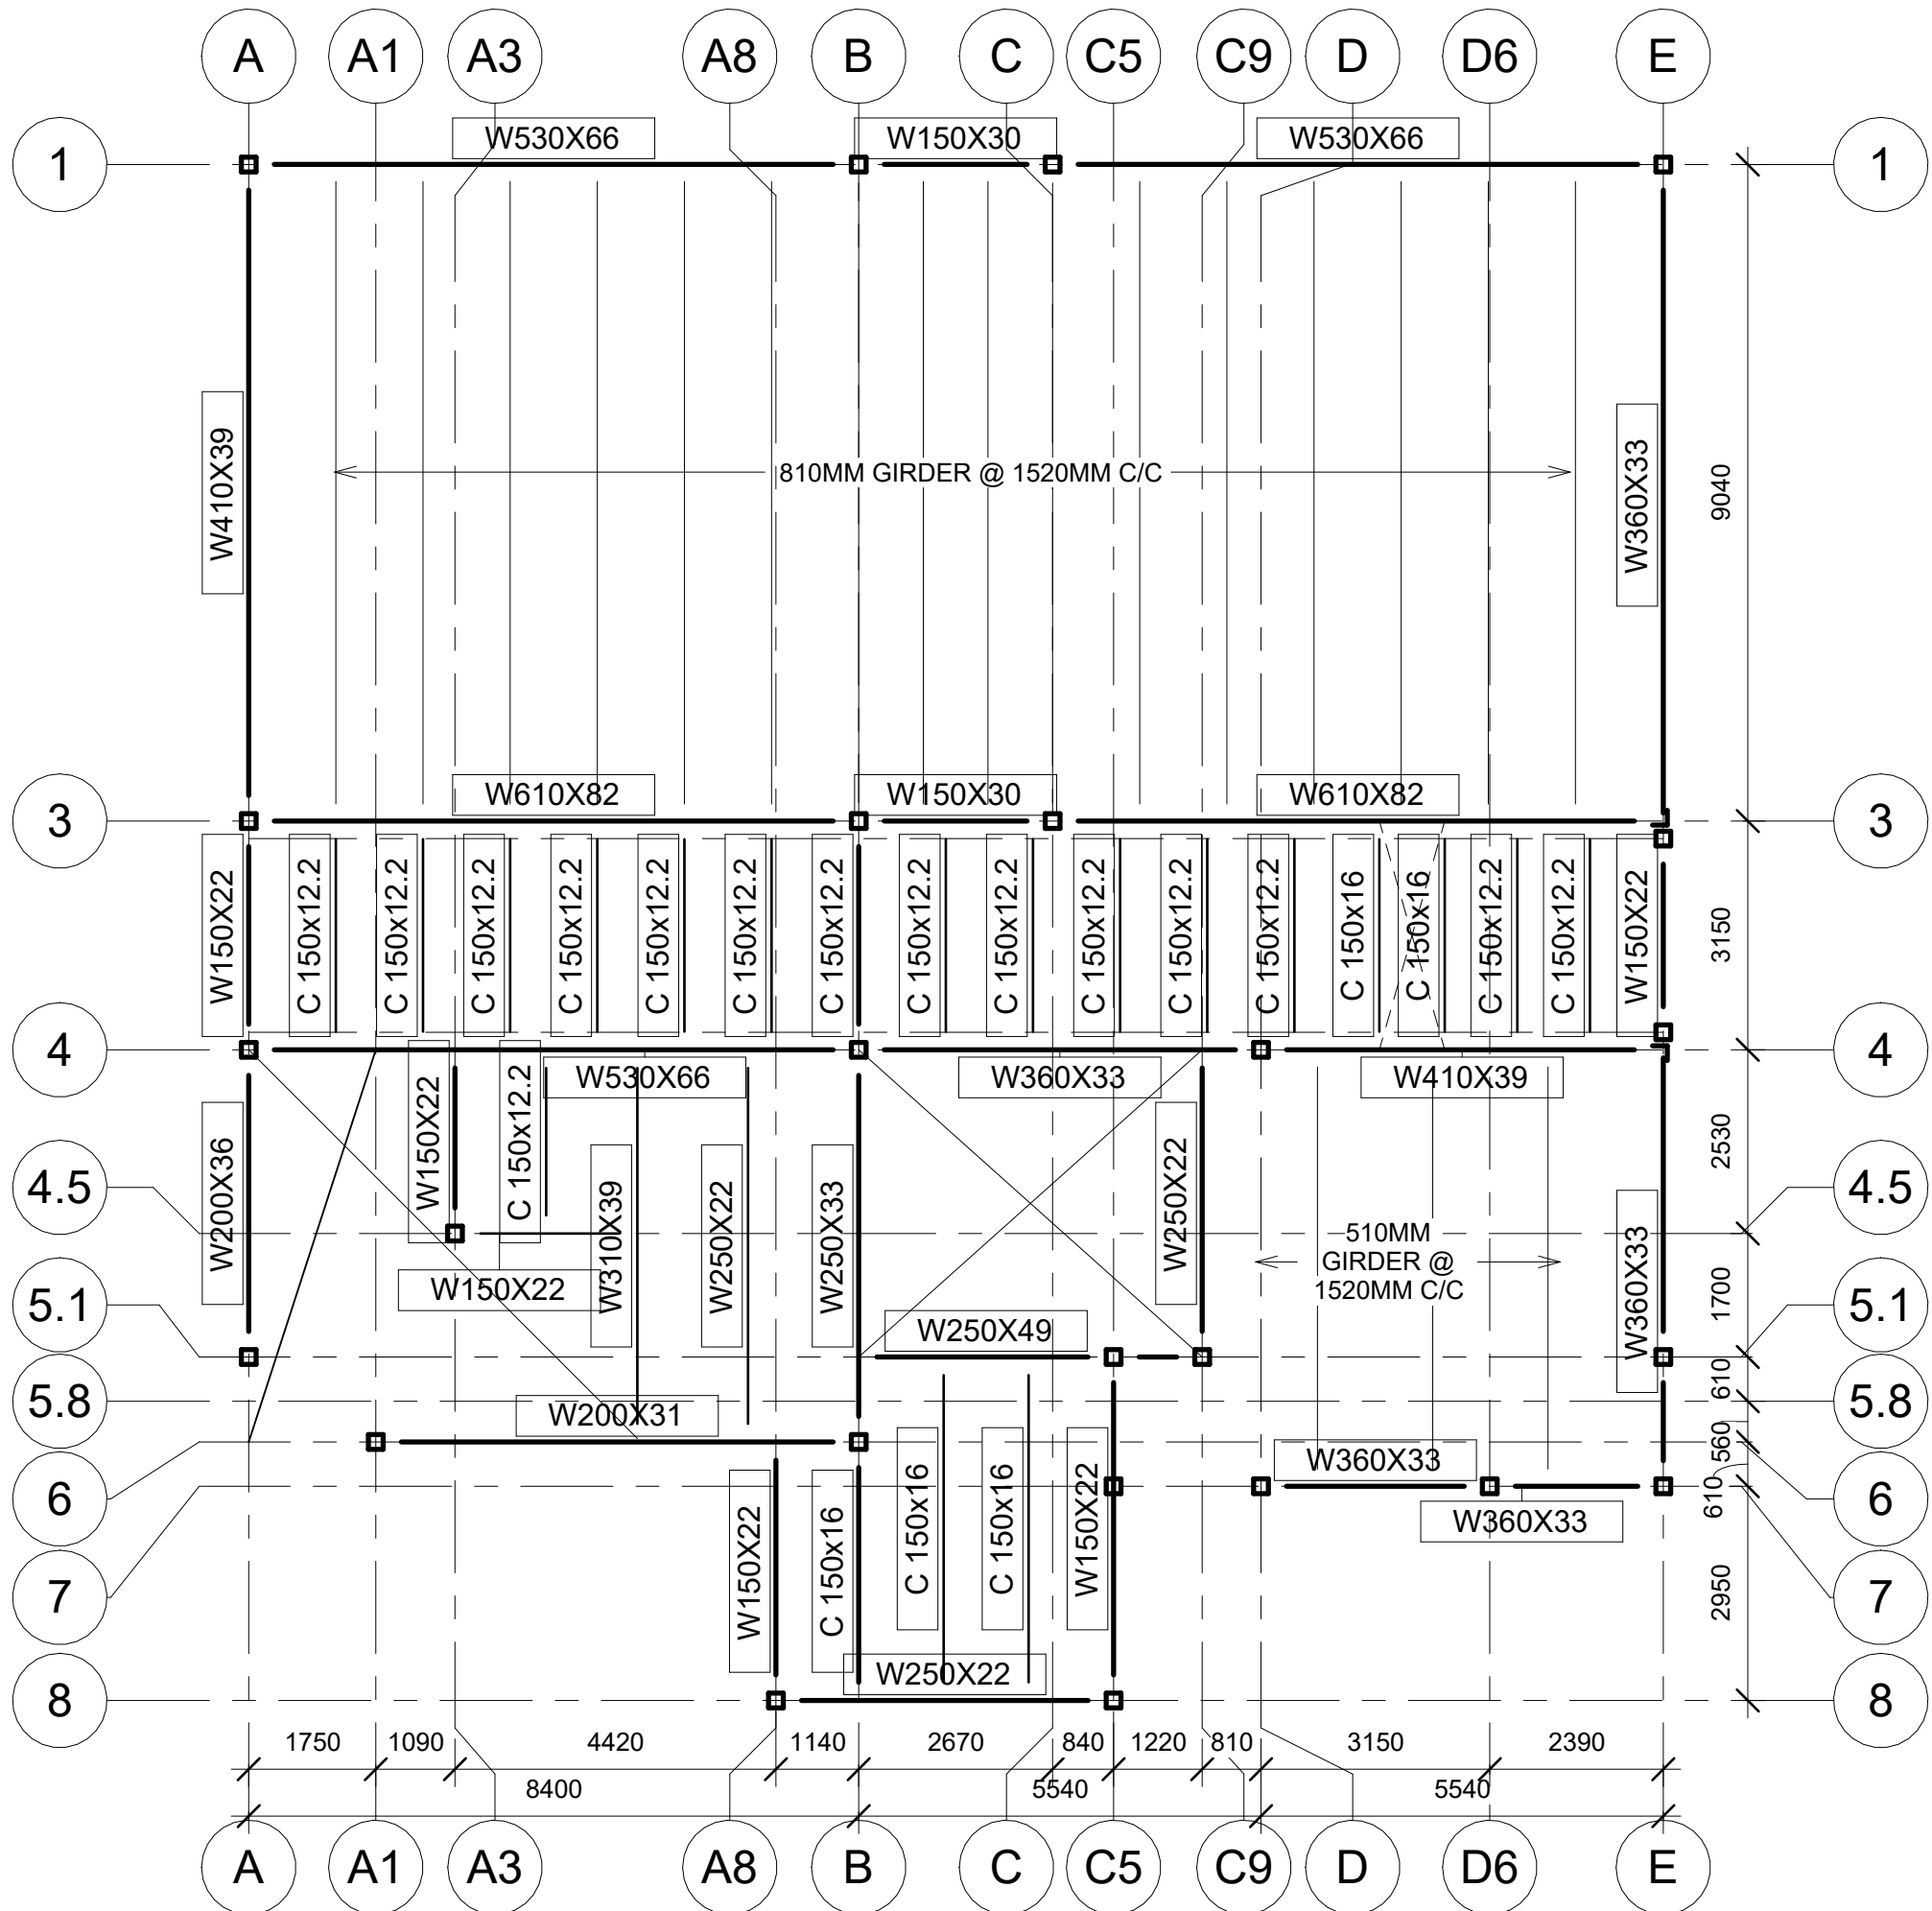


1 SECOND FL  
1 : 100

DRAWN BY  
JOHANNA SONOKPON

PROJECT NAME  
SCHOOL A

SHEET NAME  
SECOND FL STEEL PLAN

PROJECT NUMBER 0001	S-102
CHECKED BY H.K.	
DATE 09/02/25	
SCALE 1 : 100	

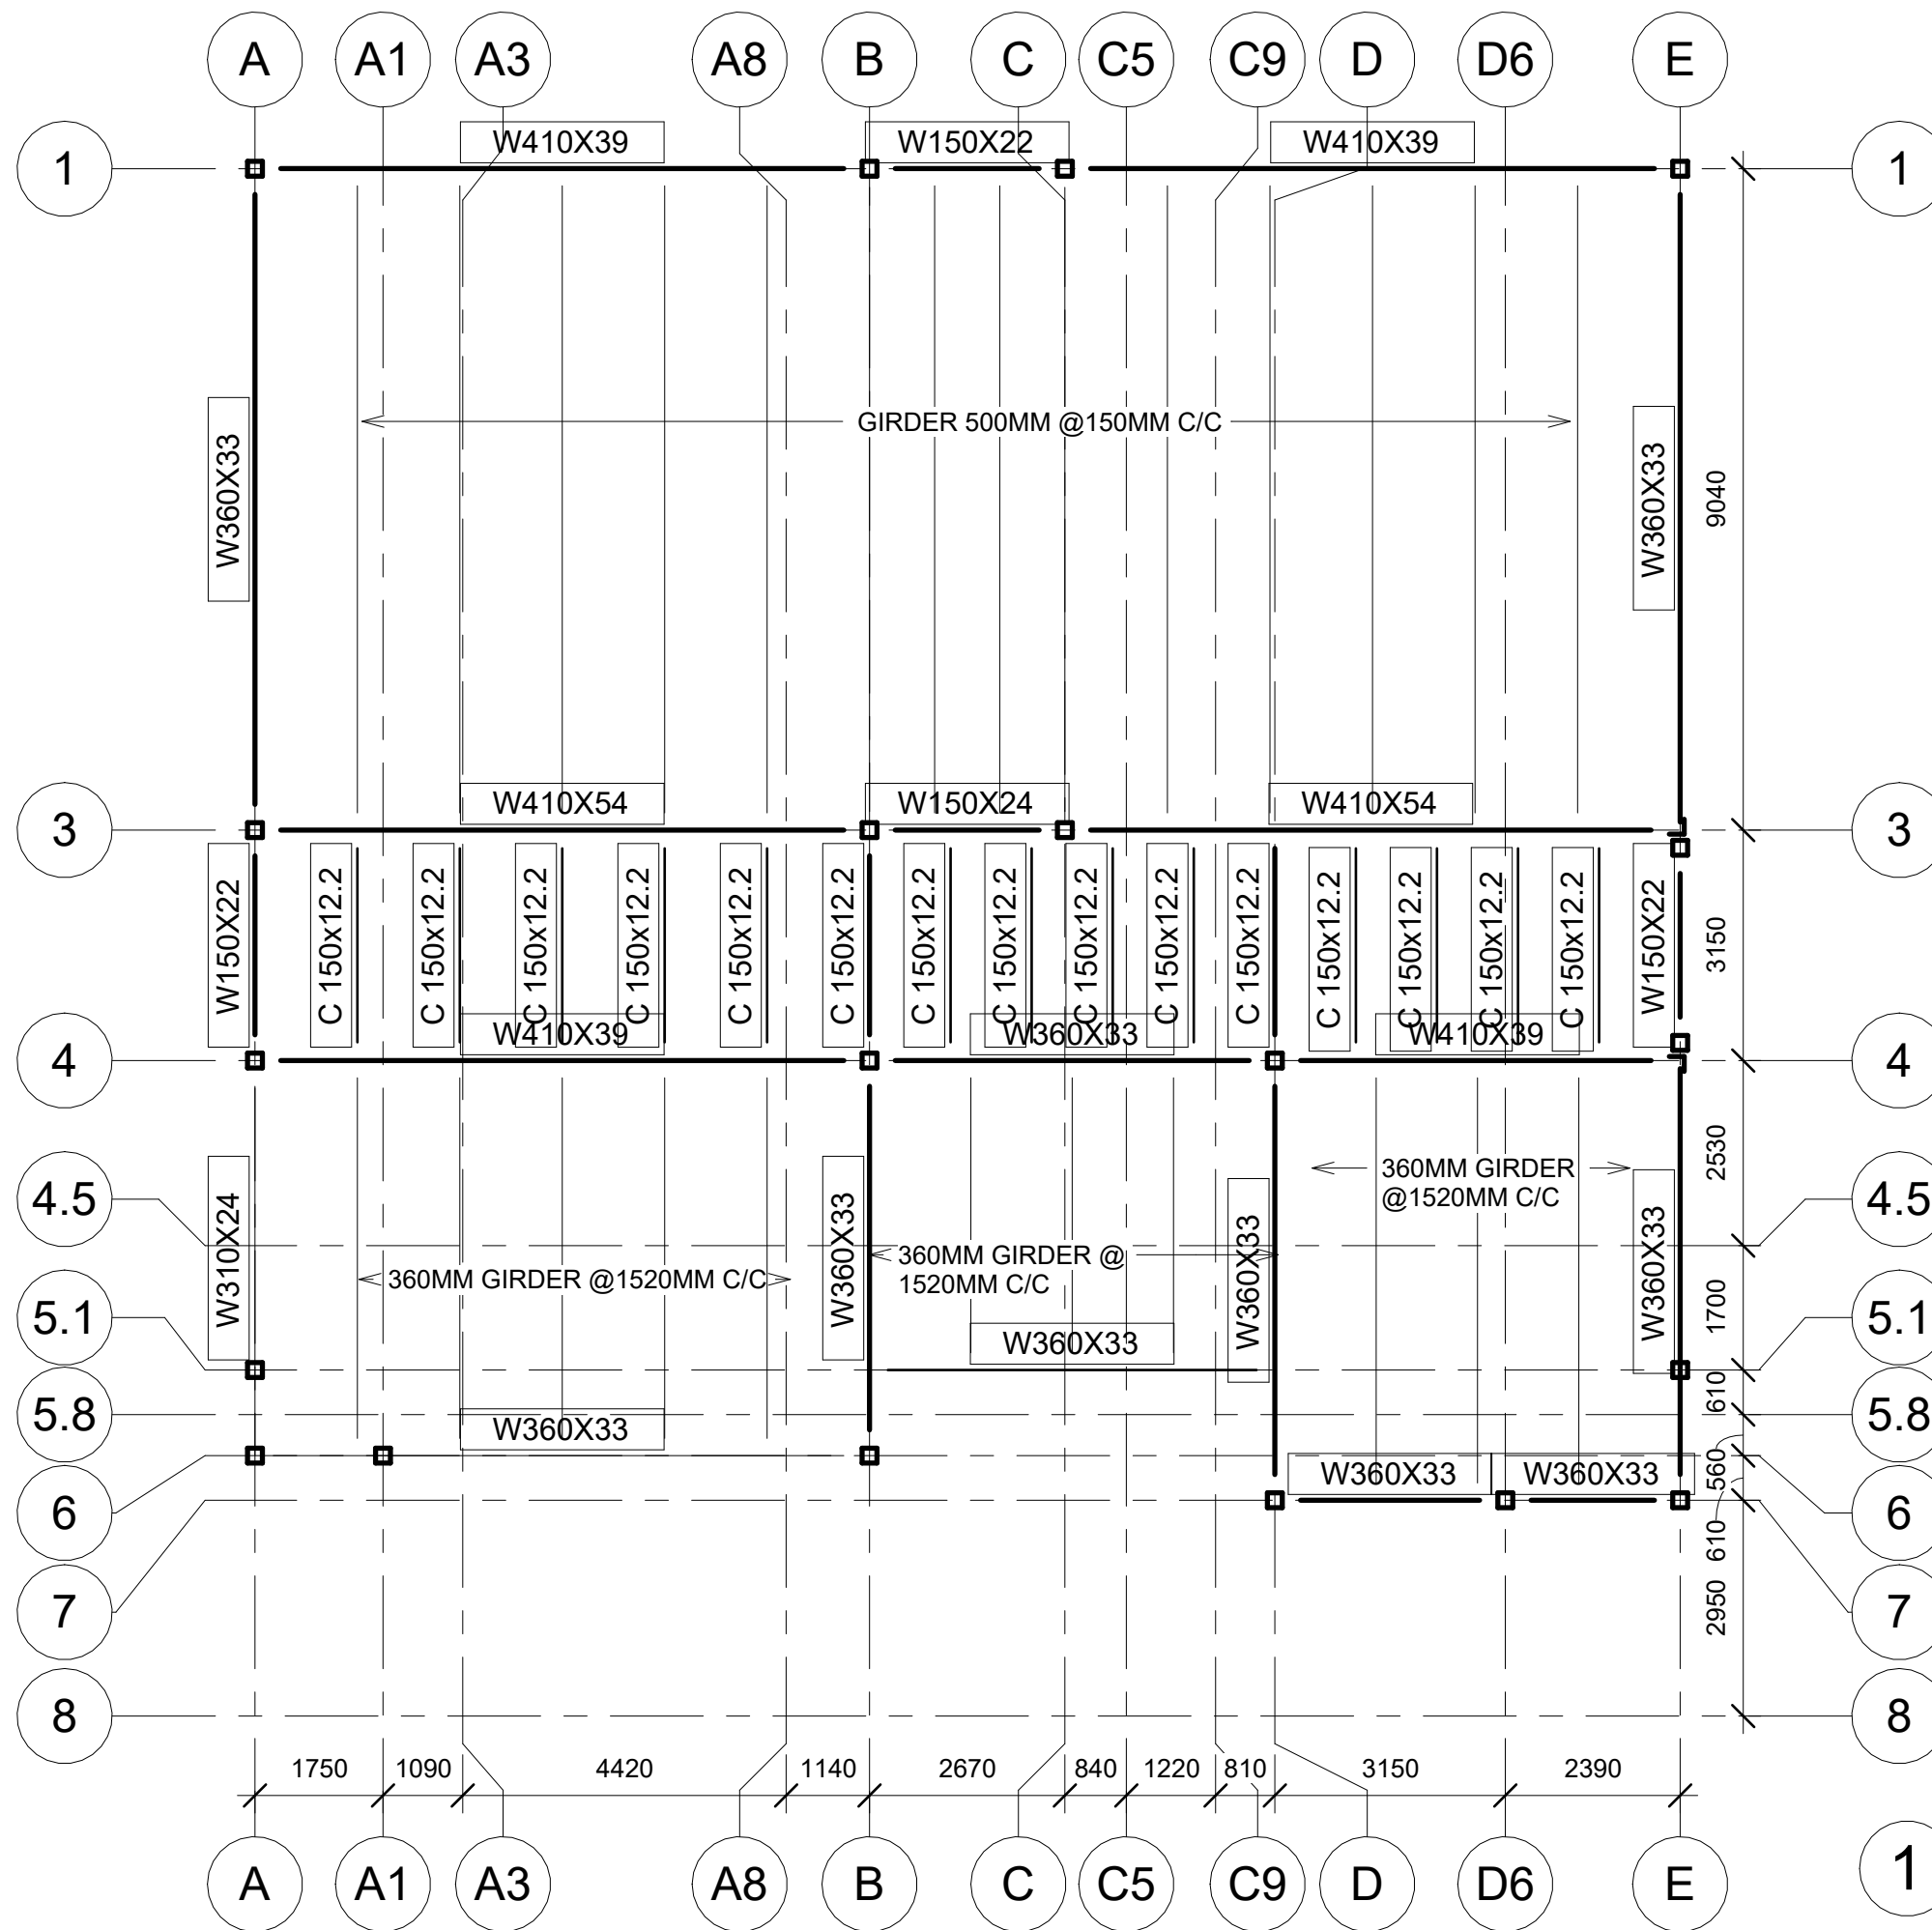

**T.O.S ROOF**  
1 : 100

**GENERAL NOTES**

DRAWN BY  
**JOHANNA SONOKPON**

PROJECT NAME  
**SCHOOL A**

SHEET NAME  
**T.O.S ROOF STEEL PLAN**

PROJECT NUMBER  
0001  
CHECKED BY  
H.K.  
DATE  
09/02/25  
SCALE  
1 : 100

**S-103**

GENERAL NOTES

DRAWN BY

JOHANNA SONOKPON

PROJECT NAME

SCHOOL A

SHEET NAME

SECOND FL STEEL PLAN


SECTION  
0001

CHECKED BY  
H.K.

DATE  
09/02/25


SCALE  
1:100

S-102

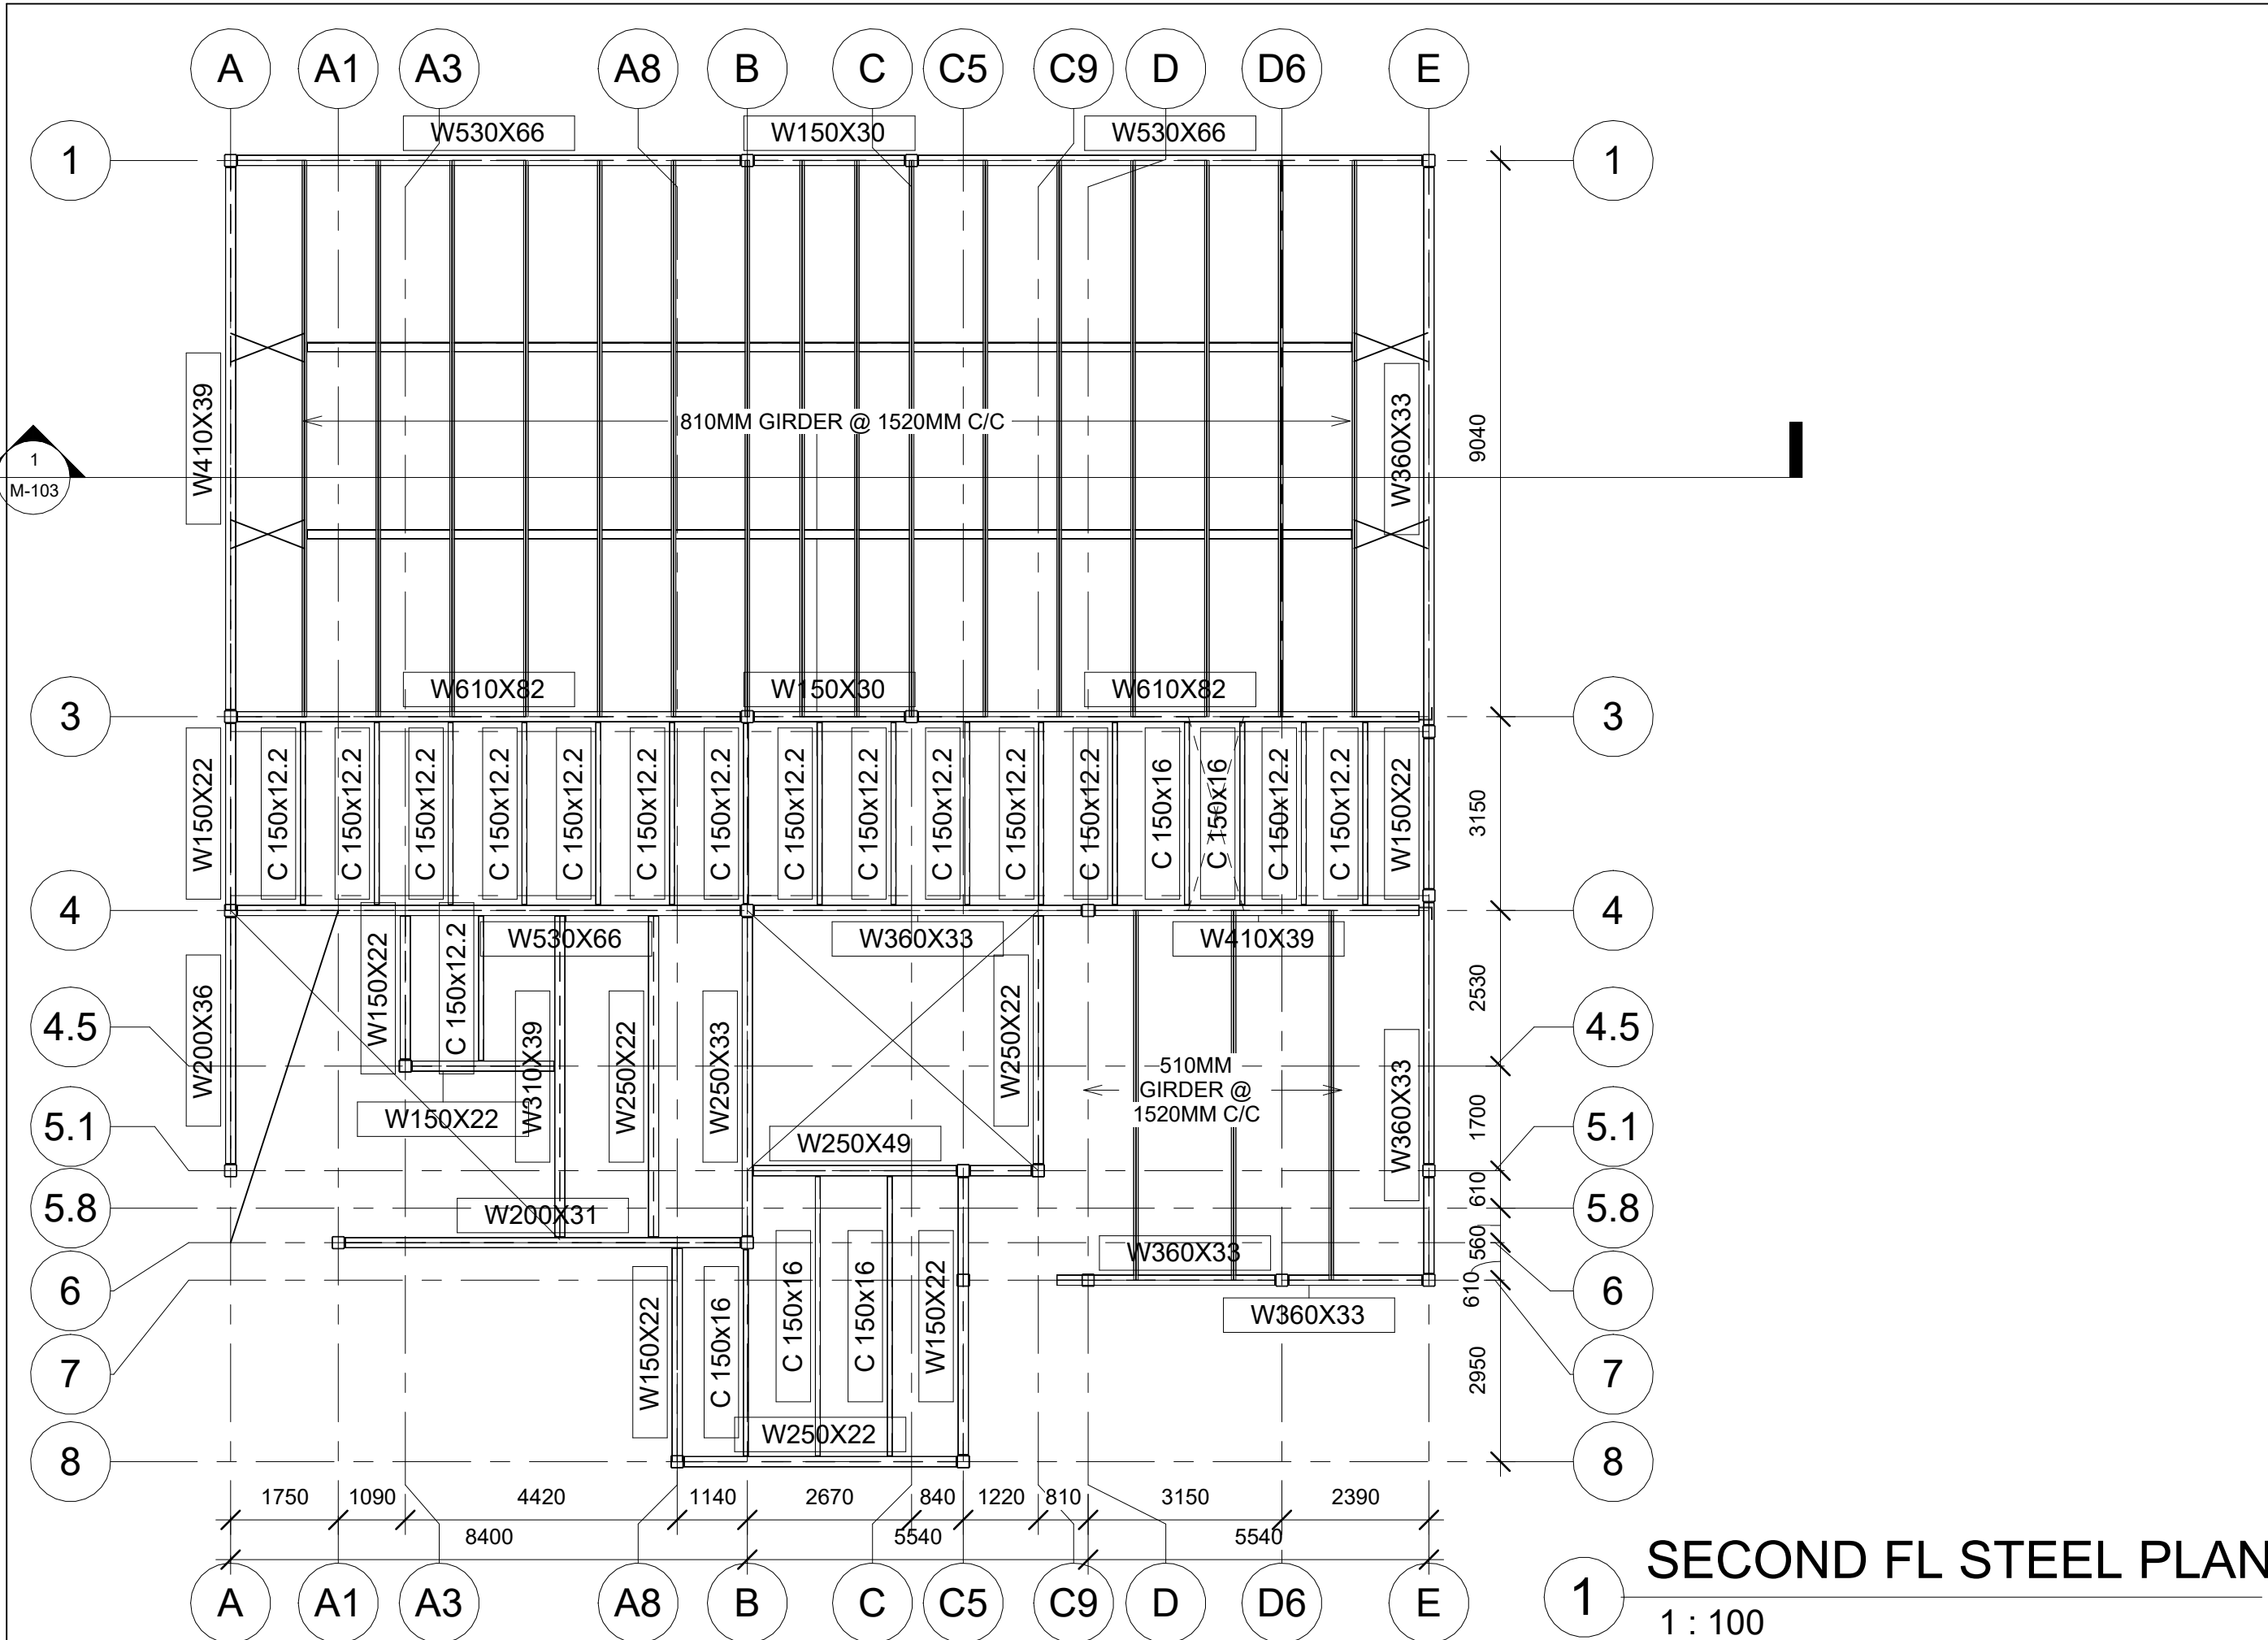

SECOND FL STEEL PLAN

1 : 100

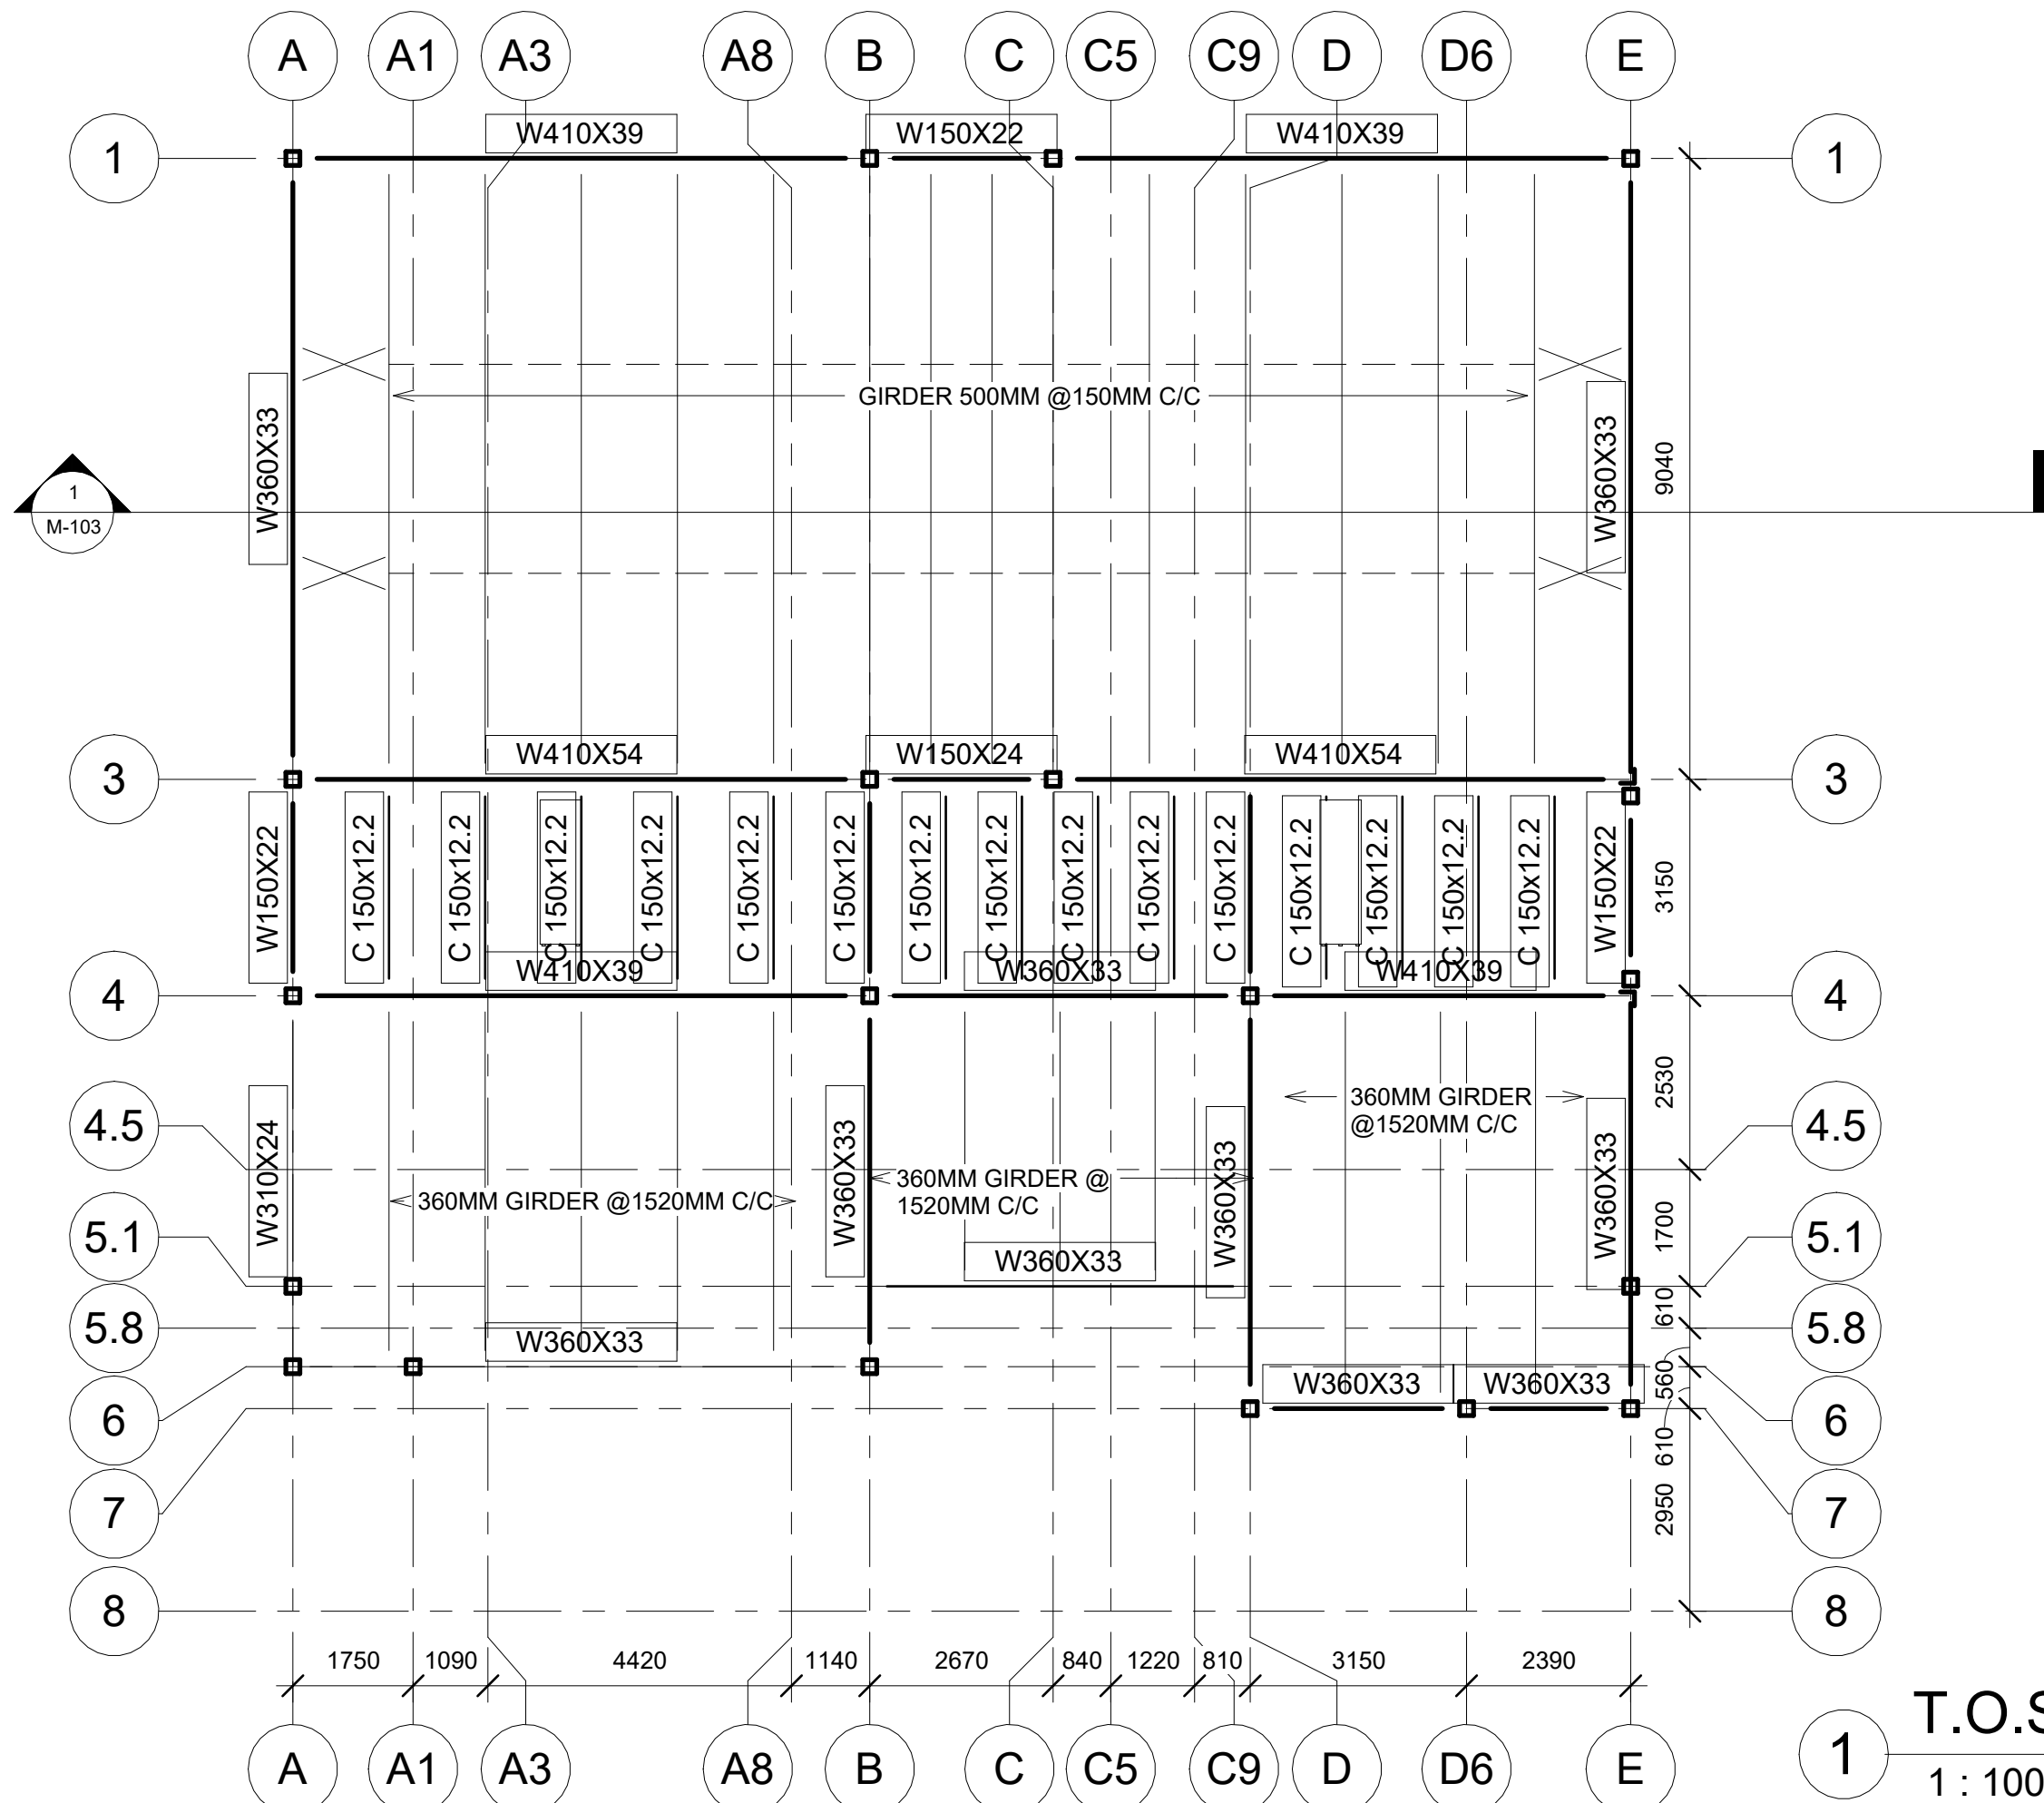

**T.O.S ROOF**  
1 : 100

**GENERAL NOTES**


DRAWN BY  
**JOHANNA SONOKPON**

PROJECT NAME  
**SCHOOL A**

SHEET NAME  
**T.O.S ROOF STEEL PLAN**

SECTION  
0001  
CHECKED BY  
H.K.  
DATE  
09/02/25  
SCALE  
1 : 100

**S-103**

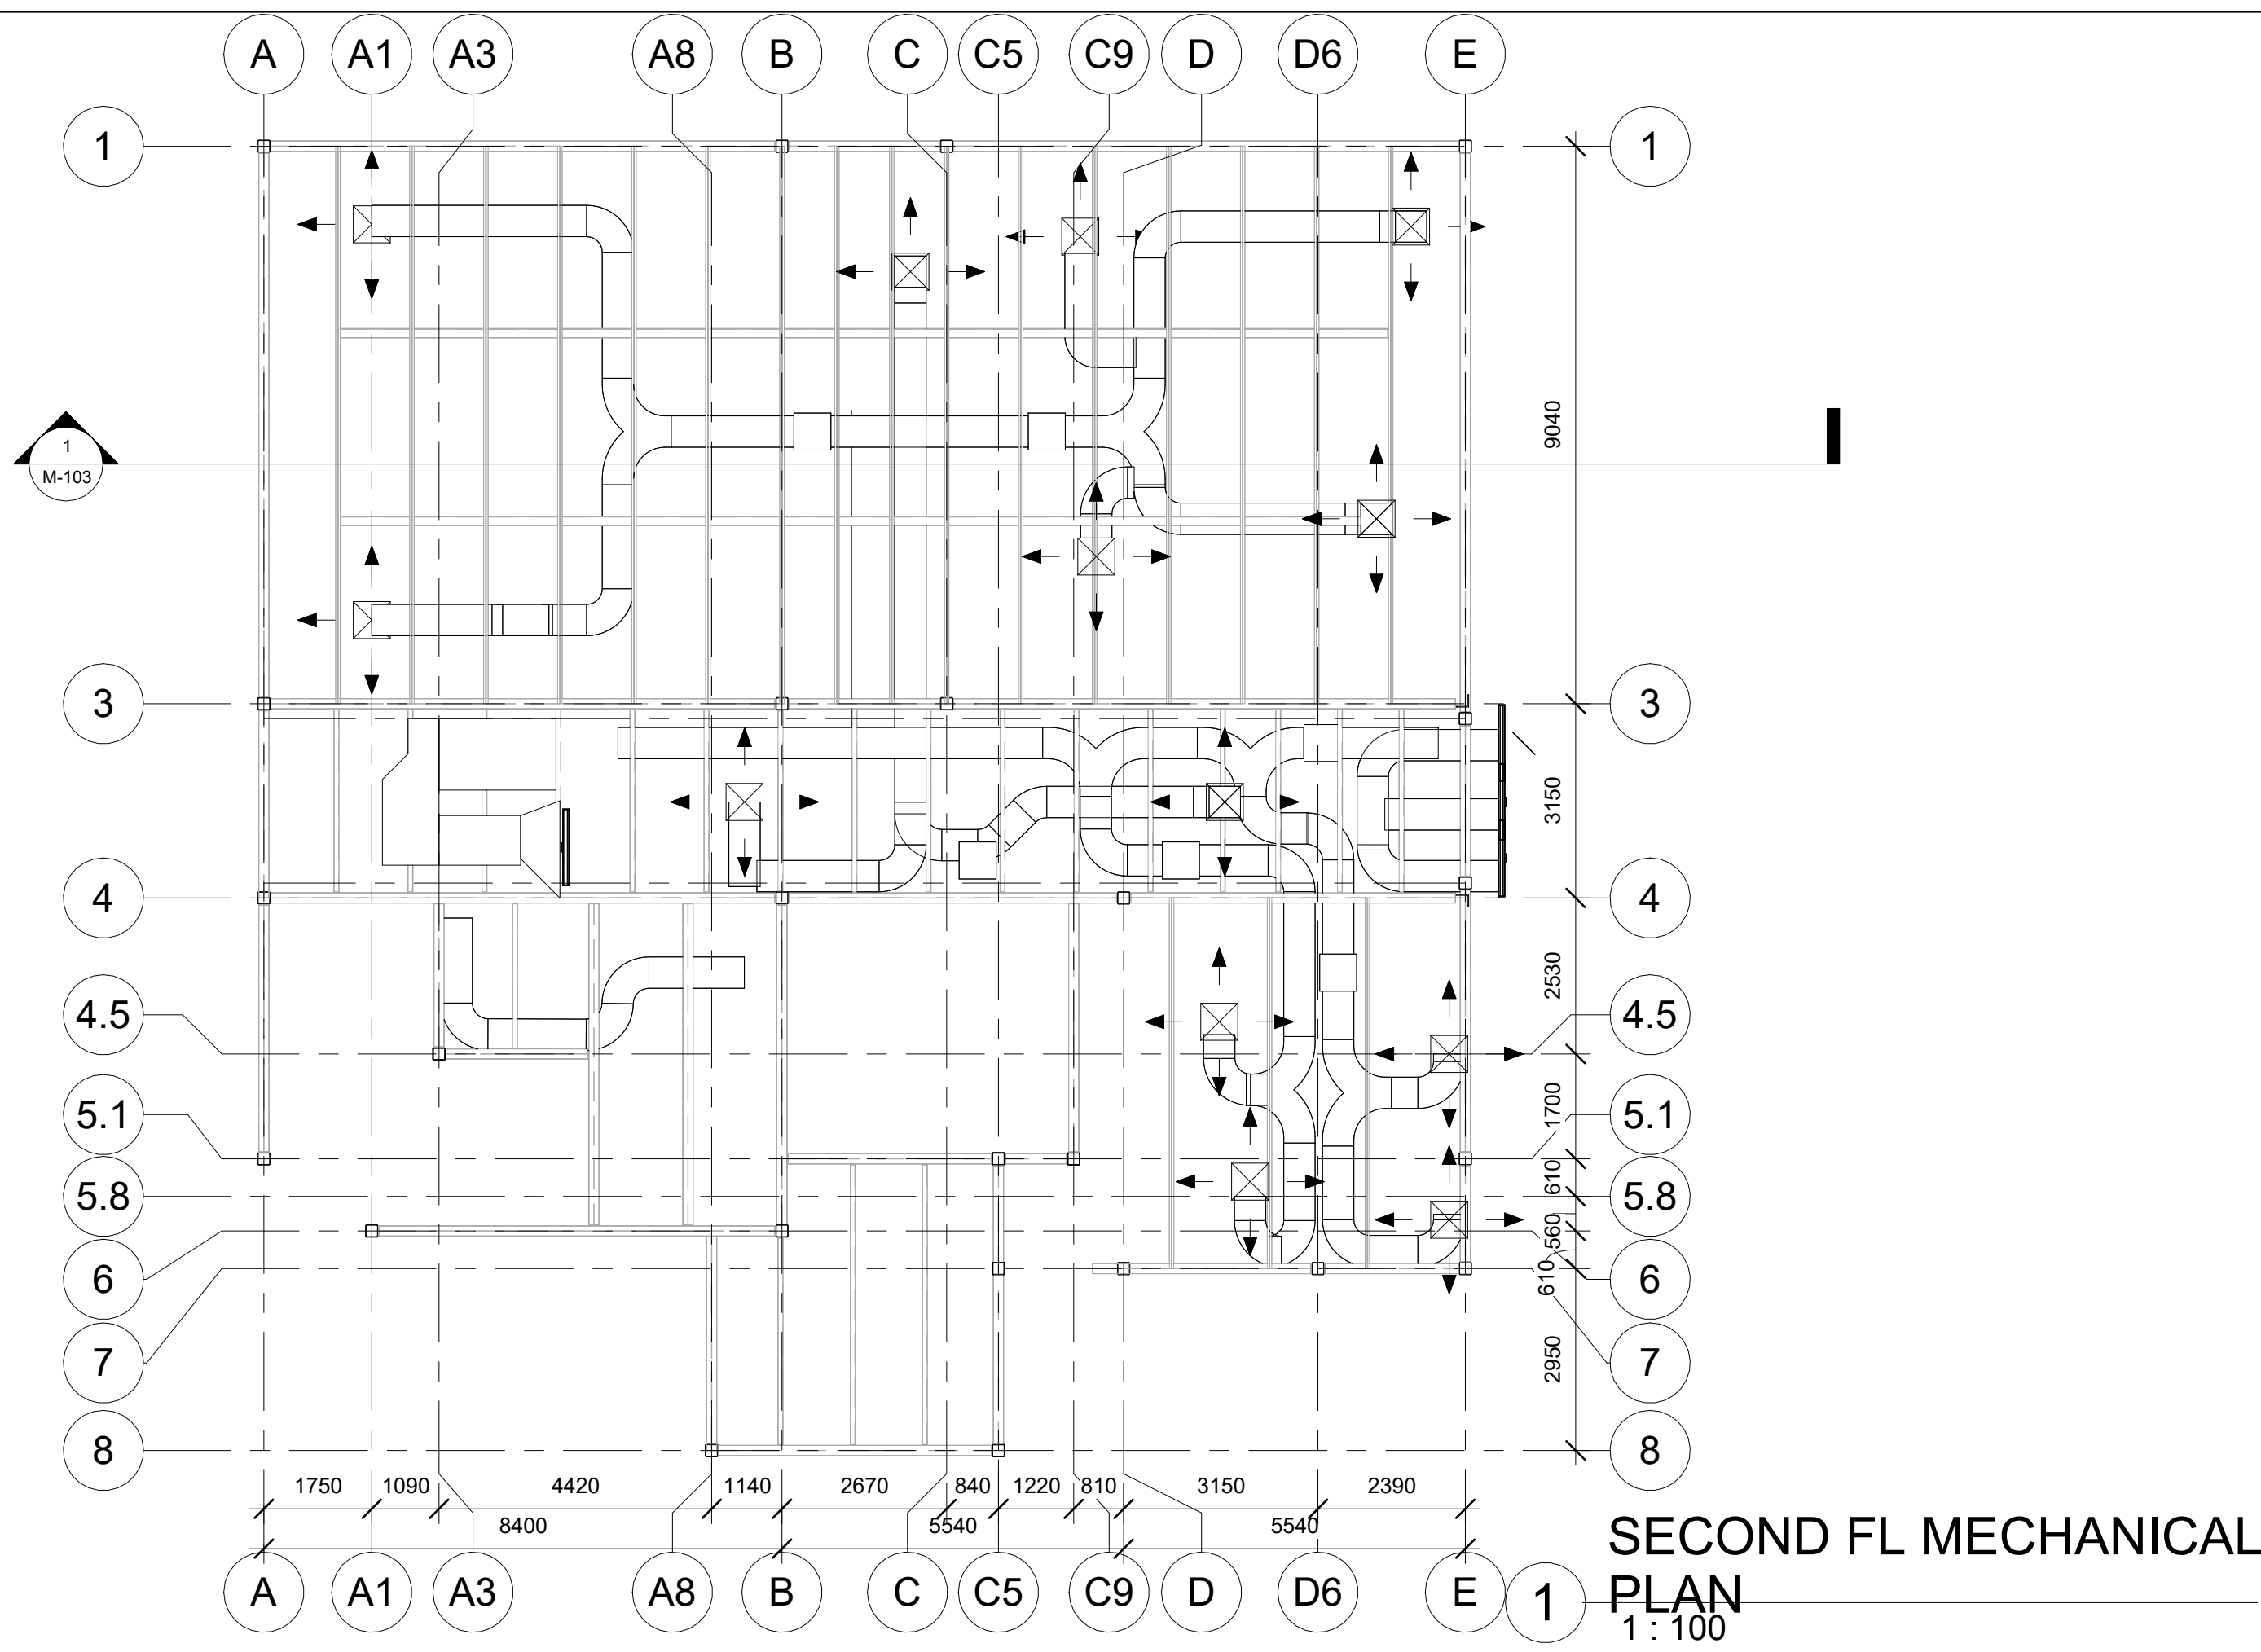

**GENERAL NOTES**

DRAWN BY

JOHANNA SONOKPON

PROJECT NAME

SCHOOL A

SHEET NAME

SECOND FL  
MECHANICAL PLAN

SECTION  
0001


CHECKED BY  
H.K.

DATE  
09/16/25

SCALE  
1:100

**M-101**

**SECOND FL MECHANICAL  
PLAN**  
1:100

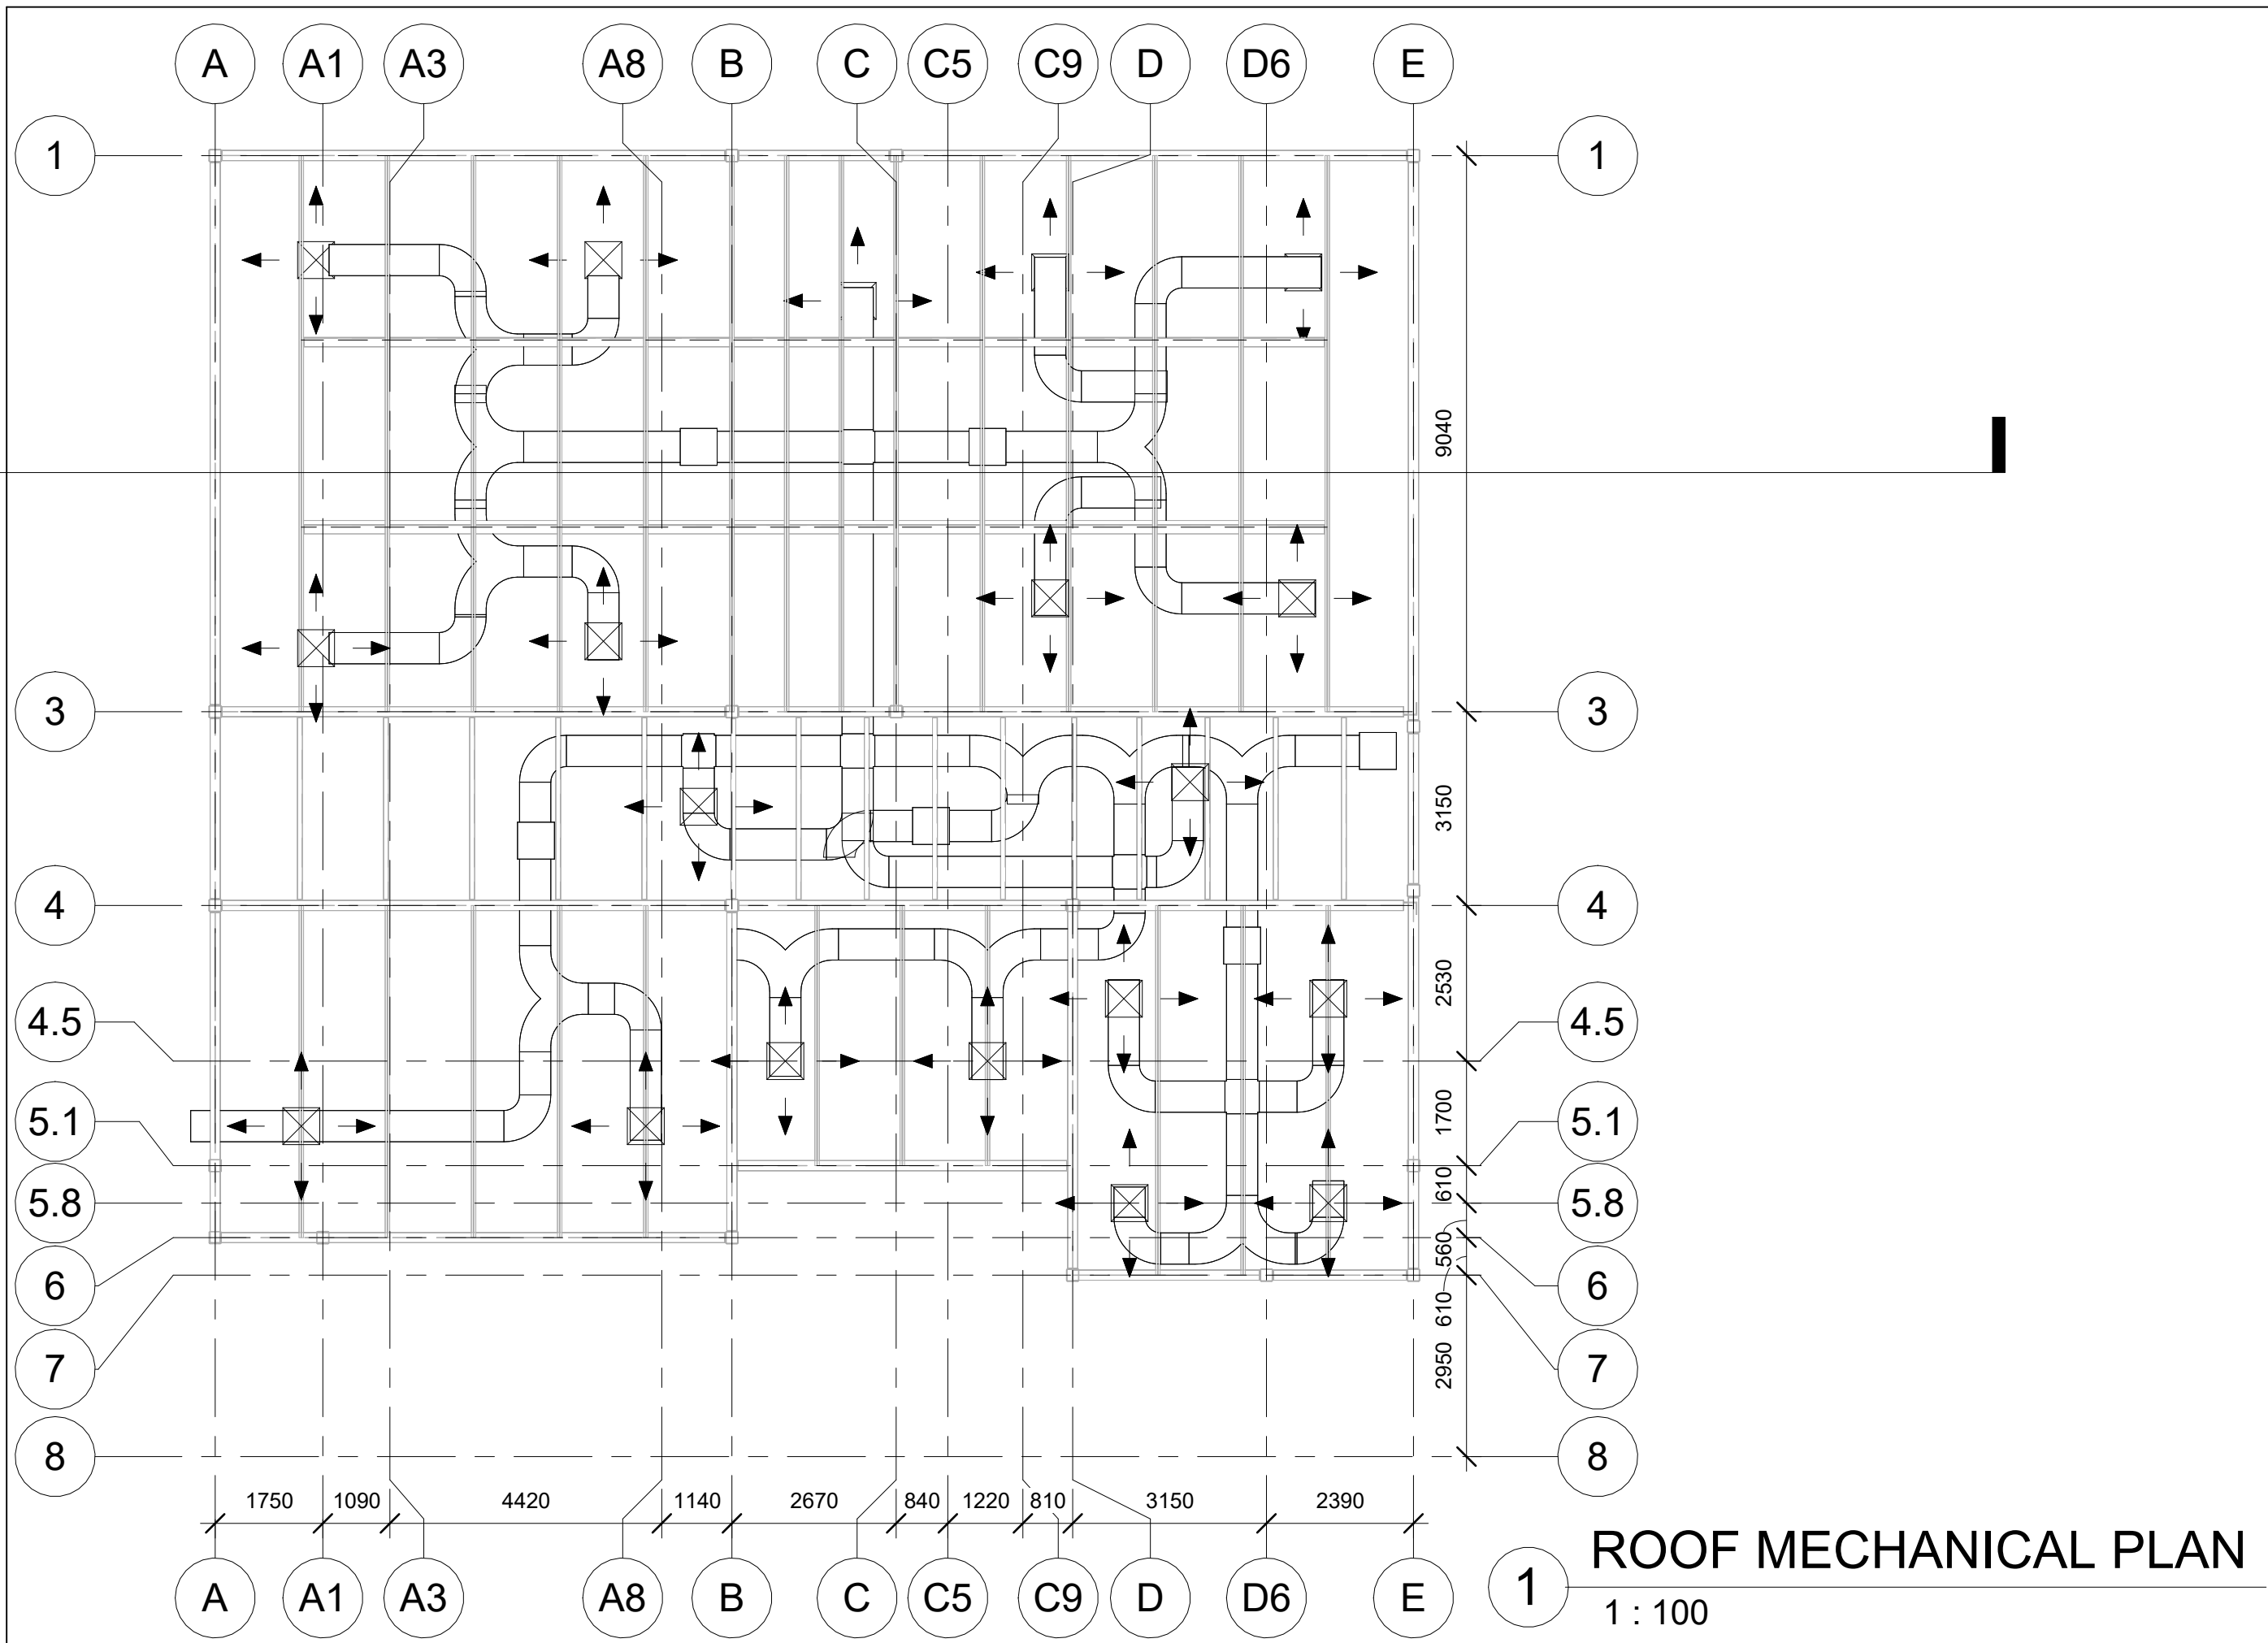

**GENERAL NOTES**

DRAWN BY

JOHANNA SONOKPON

PROJECT NAME

SCHOOL A

SHEET NAME

ROOF  
MECHANICAL PLAN

SECTION  
0001

CHECKED BY  
H.K.

DATE  
09/16/25


SCALE  
1:100

**M-102**

**ROOF MECHANICAL PLAN**

1 : 100

**GENERAL NOTES**

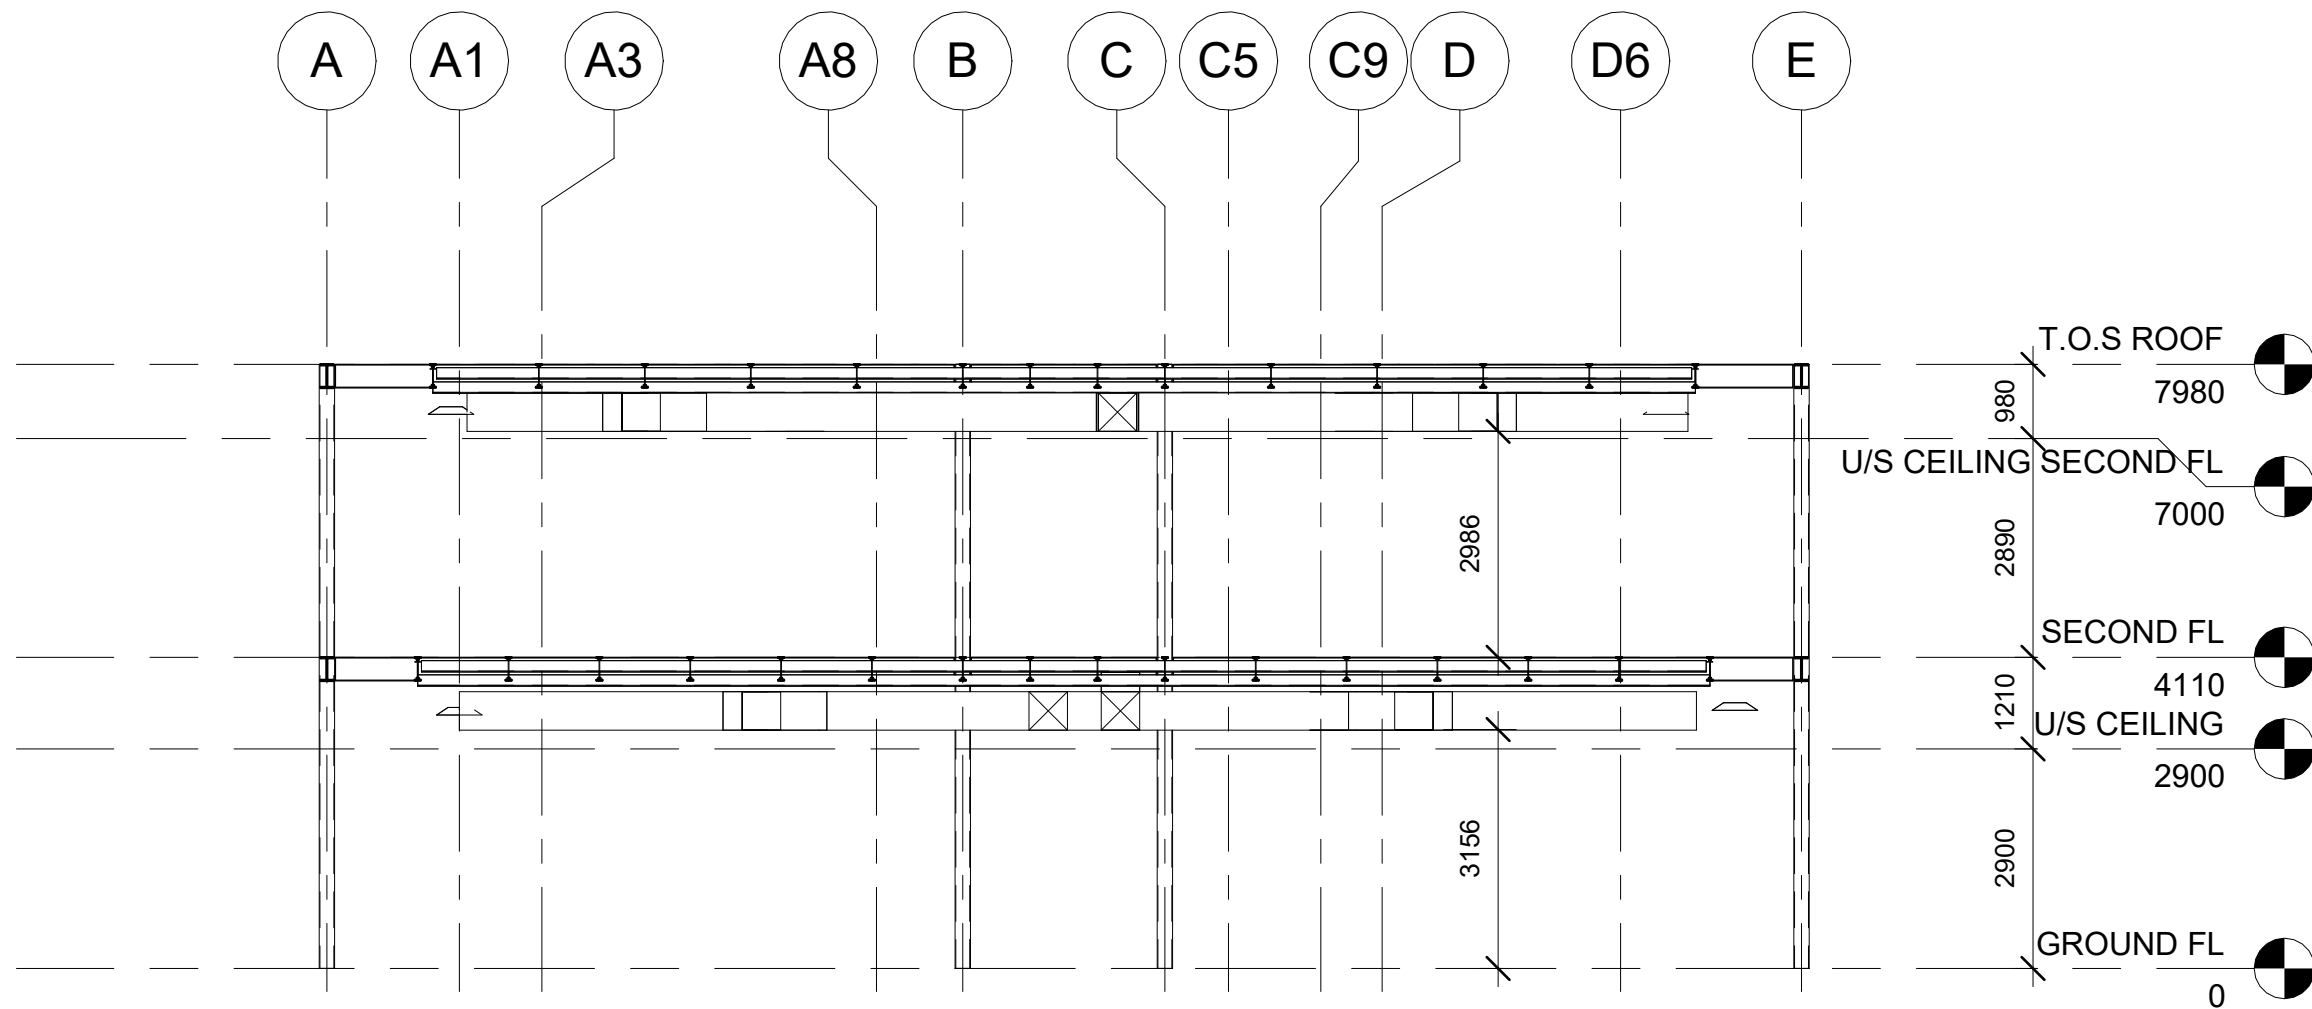

**1 BUILDING SECTION**  
1 : 100

NOTE  
THE HEADROOM IS BIGGER THAN 2745MM ON BOTH FLOORS

DRAWN BY  
**JOHANNA SONOKPON**

PROJECT NAME  
**SCHOOL A**

SHEET NAME  
**BUILDING SECTION**

SECTION	0001
CHECKED BY	H.K.
DATE	09/16/25
SCALE	1 : 100

**M-103**